



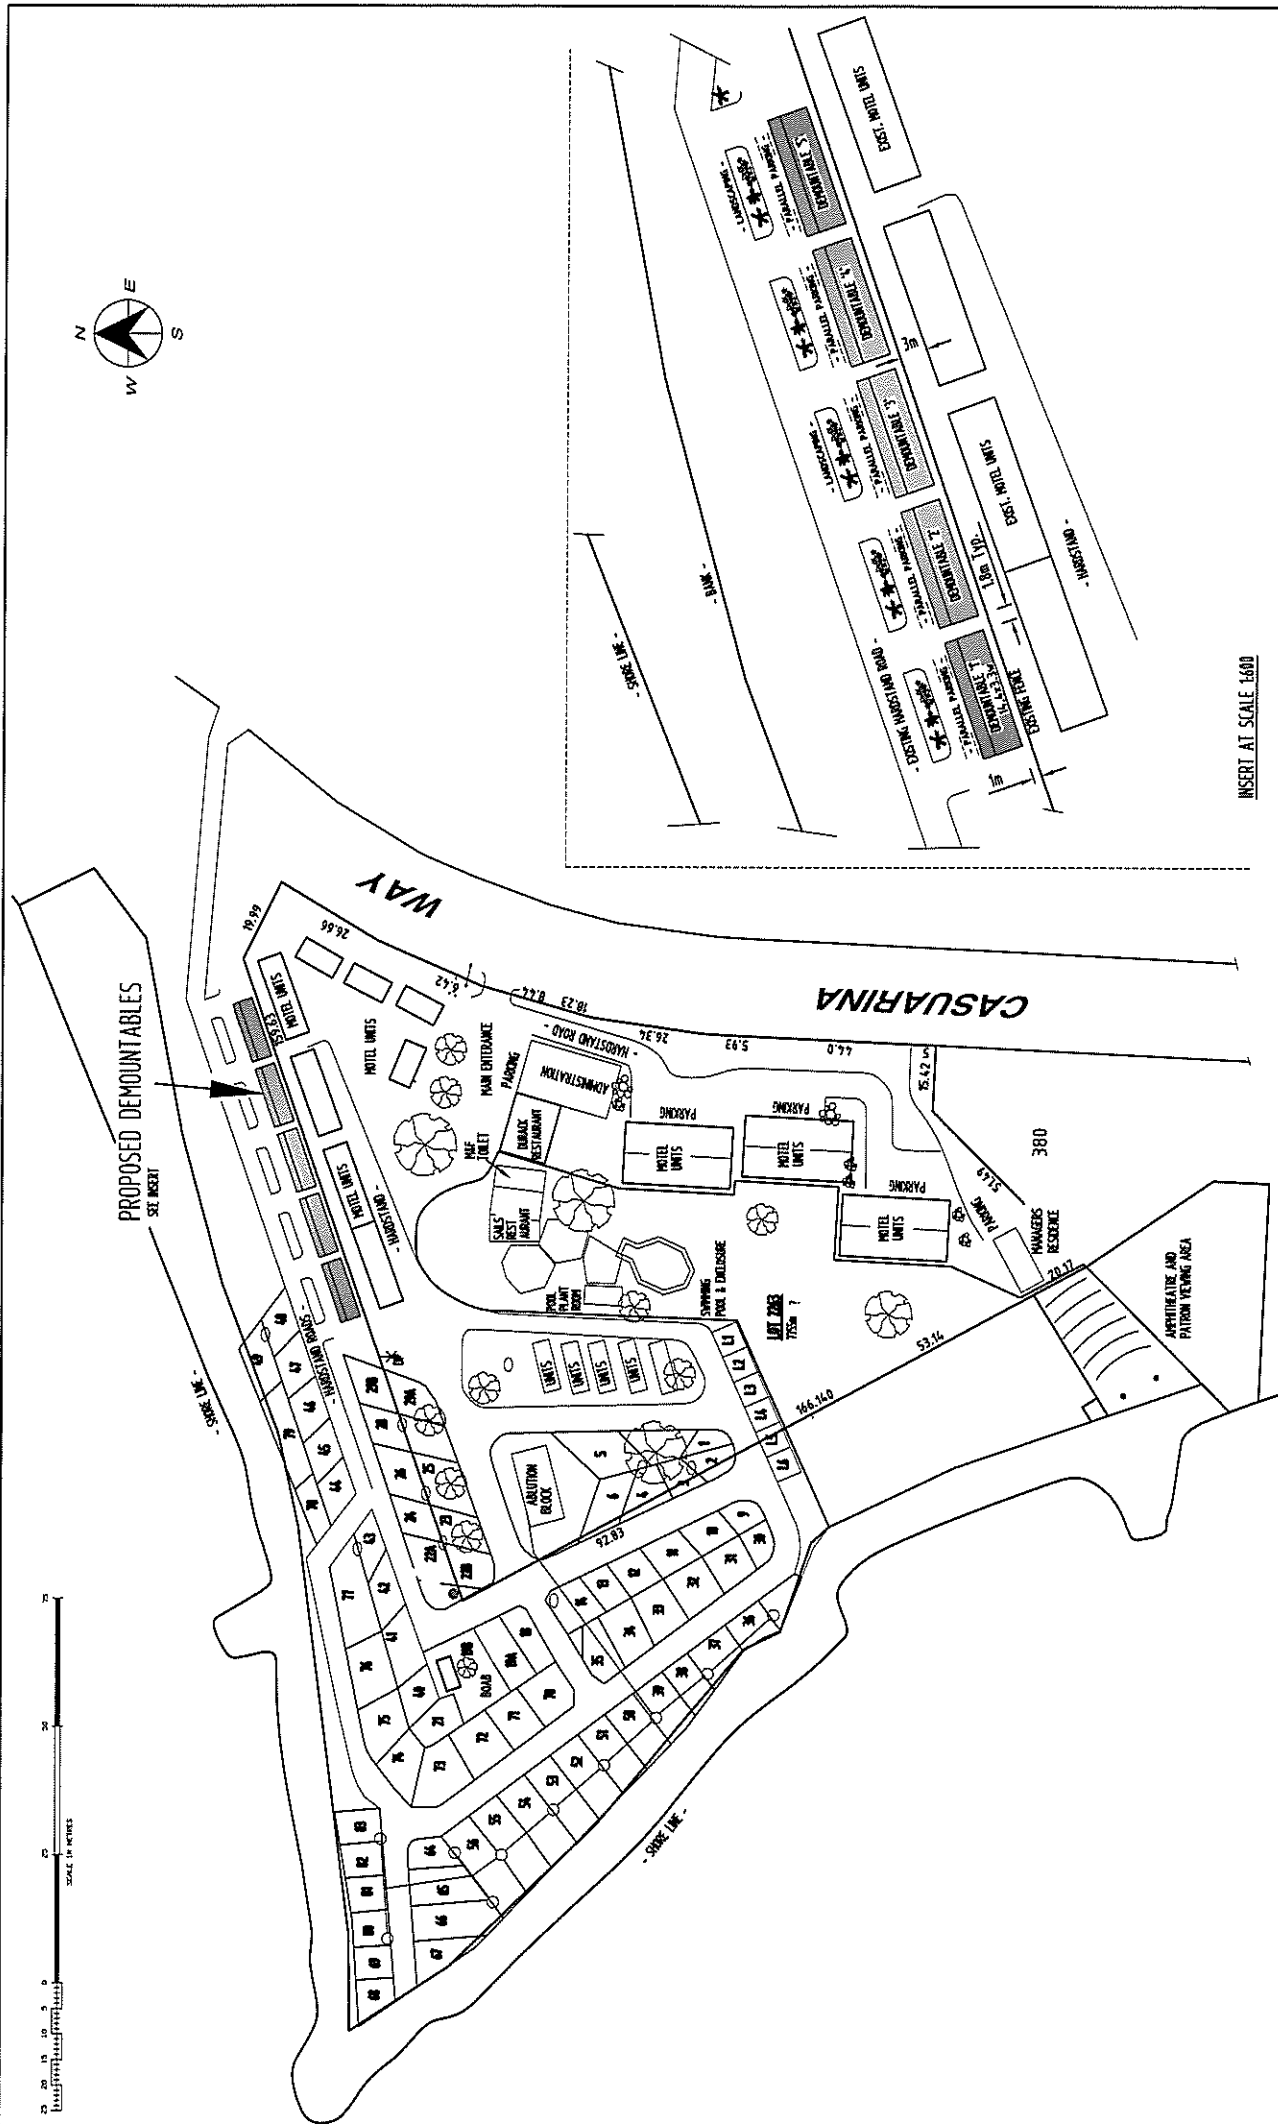

INSERT AT SCALE 1:600

[illegible]

ELEVATION

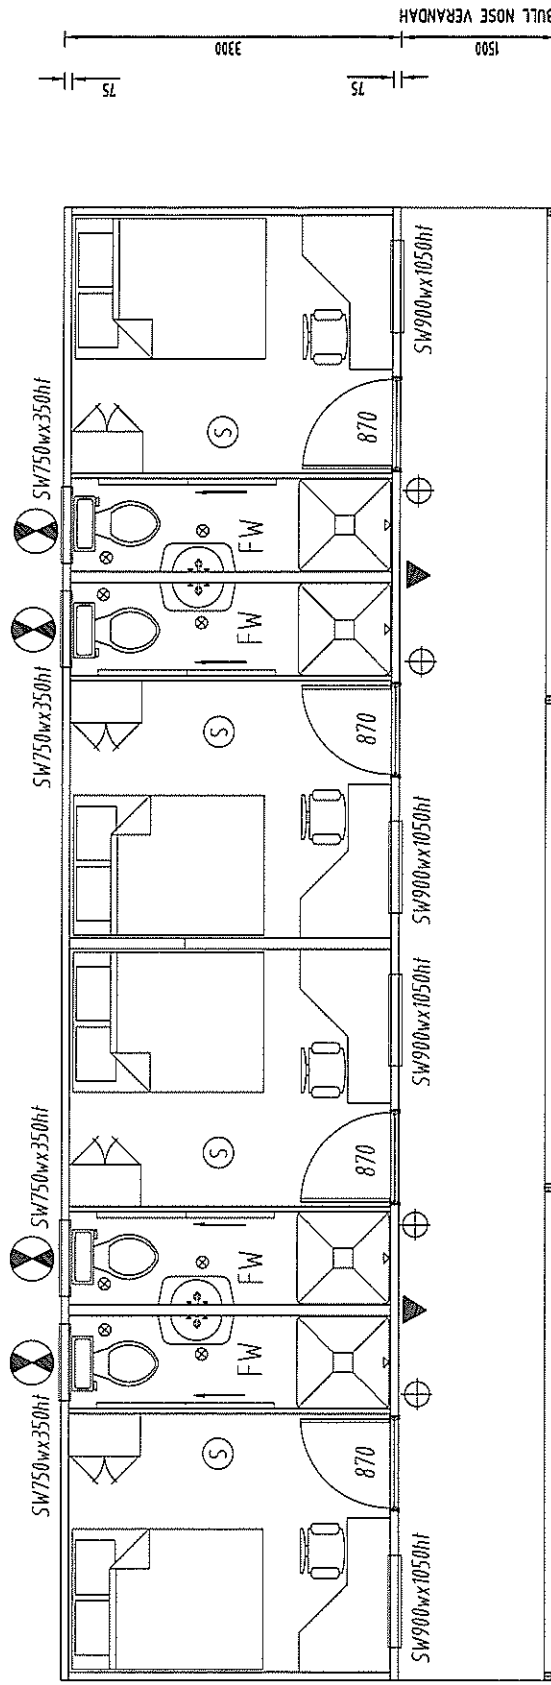

ELEVATION

-  MECHANICAL VENTILATION TO EXTERNAL AIR
 FLOOR WAIST
 HARDWIRED SMOKE DETECTOR
 EMERGENCY LIGHTING
 PORTABLE FIRE EXTINGUISHER CLASS ABE
 TO PART E1.6 BCA PART VOL.1-2009

ELEVATION 

ELEVATION

DO NOT SCALE - IF IN DOUBT ASK

NORTHERN DESIGN CONSULTANTS

D. R. READ P.O. BOX 34 KUMULU, ALA. 6743										DATE		150		 NORTHERN DESIGN CONSULTANTS	
TELEPHONE 08-91691632										DR		27-06-18		CONTRACT NO.	
FAX 08-91691630										OR		27-06-18		EQUIPMENT NO.	
MOBILE 0408-353726										PROJECT ENG				TITLE	
ISSUED FOR APPROVAL										APPROVED				PROPOSED TOURIST ACCOMMODATION FOR LANESIDE RESORT FLOOR PLAN	
RETURNS										MADE		DO		SHT 1 OF X	
REV										DATE		XXX-X-XXX		SECTION X	
XXX										XXX-X-XXX		XXX-X-XXX		PROJECT X	
- REFERENCE DRAWING TITLE										ORIG. NO.		XXX-X-XXX		REV. A	
														LSR-D-002	

ELEVATION
SCALE 150

ELEVATION
SCALE 150

ELEVATION
SCALE 150

ELEVATION
SCALE 150

DO NOT SCALE - IF IN DOUBT ASK

D.R. READ										DATE		150		 NORTHERN DESIGN CONSULTANTS		TITLE PROPOSED TOURIST ACCOMMODATION FOR LAKESIDE RESORT ELEVATIONS		PROJECT X SECTION X		REV. A LSR-D-003			
FORM 34 KANSAS, INC. 4713 TELEPHONE 08-91691612 FAX 0408-353726 MOBILE 0408-353726										DRAWN BY DR CHECKED DR PROJECT ENG.		DATE 27-06-18 27-06-18											
ISSUED FOR APPROVAL										REVISIONS		MADE		OCD		APP		A3					
XXX		XXX-X-XXX		X		27-06-18		REV		DATE													
- REFERENCE DRAWING TITLE																							

[illegible]