


ELEVATION 3
RV 07




23700



ELEVATION 1
RV 07

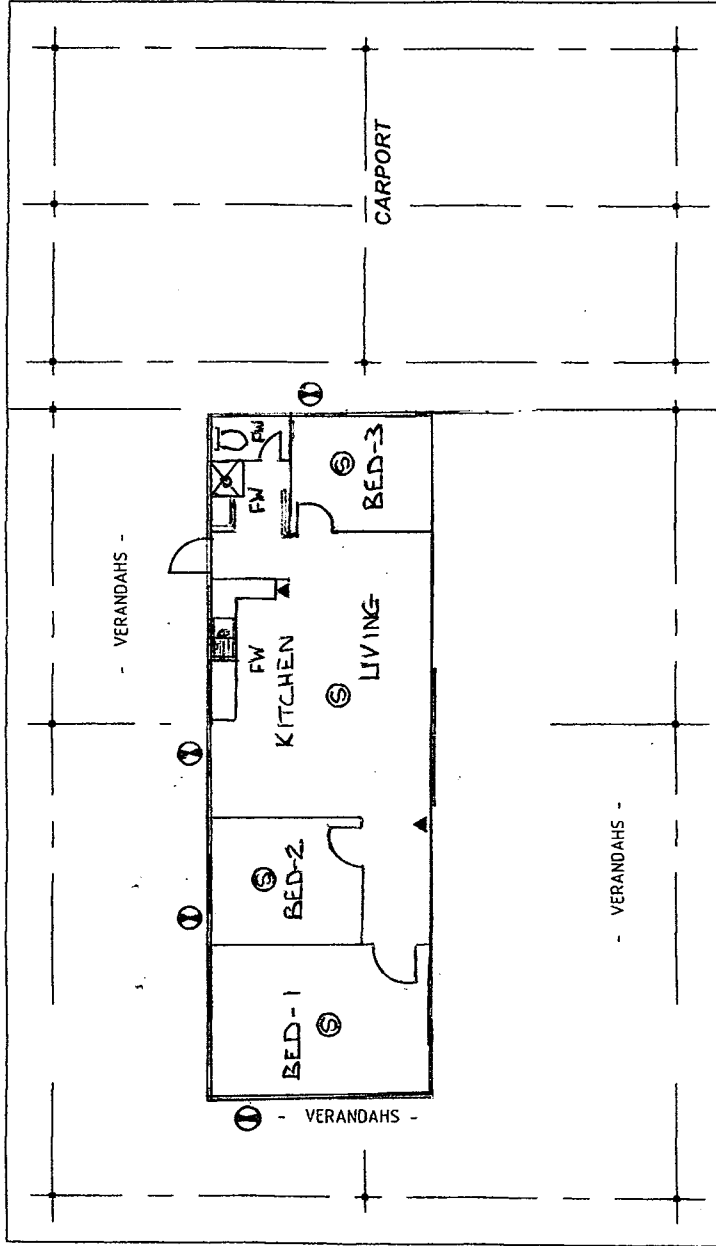

ELEVATION 2
RV 07

 

ELEVATION 4
RV 07



- ⑤ HARDWIRED SMOKE DETECTOR
- Ⓢ MECHANICAL VENTILATION TO EXTERNAL AIR
- FW FLOOR WAIST
- ▲ PORTABLE FIRE EXTINGUISHER

DO NOT SCALE - IF IN DOUBT ASK

REVISED FLOOR PLAN - CHALET 1		PROJECT X
PROPOSED ACCOMMODATION UNITS FOR ROB. & VICKY LOT 530 RIVER FARM RD FLOOR PLAN		SECTION X
SHT 1 OF 1		DRG. NO.
SCALE 1:100	CONTRACT NO.	PROJECT X
DRAWN BY	EQUIPMENT NO.	SECTION X
CHECKED		DRG. NO.
PROJECT ENG		
APPROVED		
ISSUED FOR APPROVAL	XXXXXXX	
DATE	DATE	
REV	REV	
XXX-X-XXX	XXX-X-XXX	
DRG. NO.	DRG. NO.	
REFERENCE DRAWING TITLE	REFERENCE DRAWING TITLE	